


Site Plan for;

Chatham County Emergency Operations and Communications Center

112 Innovation Way
Pittsboro, NC 27312

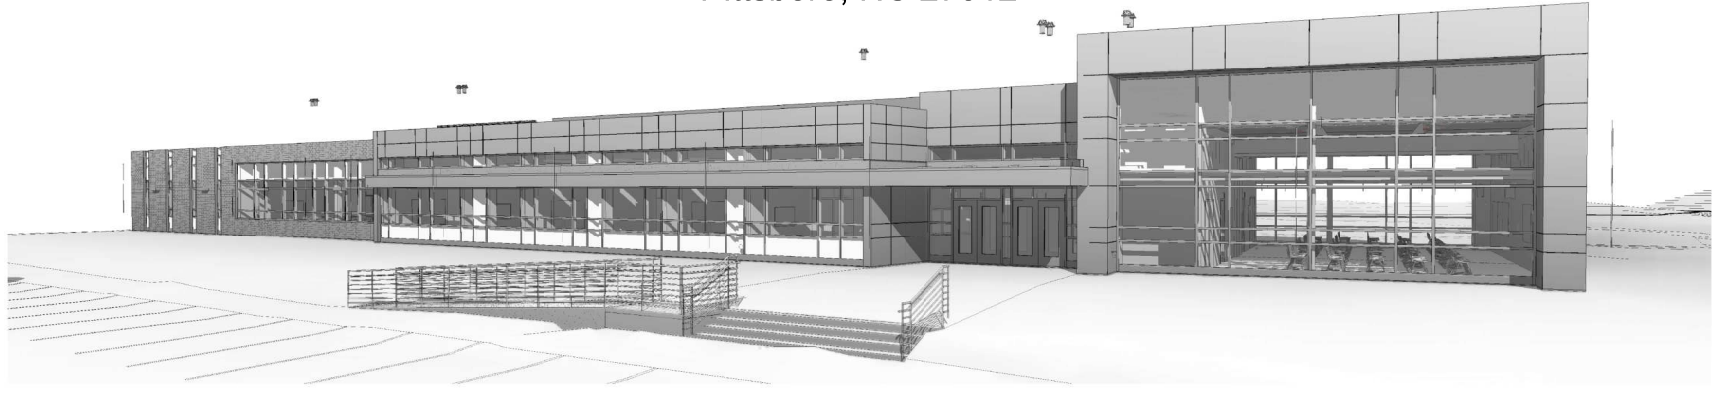

Consultants:
Civil:
WITHERSRAVENEL
115 Mackenham Drive
Cary, NC 27511
(919) 468-3340
MEP:
RMF ENGINEERING
100 East Main Street, Suite 301
Salisbury, MD 21801
(443) 736-1638
Structural Engineer:
SCHRADERGROUP
155 East King Street, Suite 211-212
Lancaster, PA 17602
(717) 299-8665

Professional Seal

Owner:
Chatham County, North Carolina
12 East Street, P.O. Box 1809
Pittsboro, NC 27312

Site Plan for:
Chatham County Emergency Operations and Communications Center
 112 Innovation Way
 Pittsboro, NC 27312

Sheet Index

CS.1	COVER SHEET
------	-------------

Civil

C0.0	GENERAL NOTES AND LEGEND
C1.0	EXISTING CONDITIONS PLAN
C2.0	OVERALL SITE PLAN
C2.1	DETAILED SITE PLAN - EAST
C2.2	DETAILED SITE PLAN - WEST
C3.0	OVERALL GRADING AND DRAINAGE
C3.1	DETAILED GRADING AND DRAINAGE
C3.2	DETAILED GRADING AND DRAINAGE
C4.0	OVERALL UTILITY PLAN
C4.1	DETAILED UTILITY PLAN - NORTH
C4.2	DETAILED UTILITY PLAN - SOUTH
C4.3	INNOVATION WAY - WATERLINE PLAN AND PROFILE
C4.4	SANITARY SEWER PLAN AND PROFILE
C4.5	OFFSITE WATER PLAN - EAST
C4.6	OFFSITE WATER PLAN - WEST
C5.0	WATERLINE DETAILS
C5.1	SANITARY SEWER DETAILS
C5.2	CONSTRUCTION DETAILS
C5.3	NGCOT DETAILS
C6.0	SCM PLAN AND DETAILS
C6.1	SCM PLAN AND DETAILS
C6.2	CULVERT DESIGN AND BYPASS PLAN
CT.0	EROSION CONTROL STAGE 1
CT.1	EROSION CONTROL STAGE 2
CT.2	RENAISSANCE DRIVE WATERLINE EXTENSION EROSION CONTROL PLAN
CT.3	EROSION CONTROL DETAILS - 1
CT.4	EROSION CONTROL DETAILS - 2
CT.5	NGCOT DETAILS

Land Development

L1.0	LANDSCAPE PLAN
L2.0	LANDSCAPE DETAILS

Architectural

A141	ROOF PLAN
A150	FIRST FLOOR FURNITURE PLAN
A201	COMPOSITE BUILDING ELEVATIONS
A202	PARTIAL BUILDING ELEVATIONS
A203	PARTIAL BUILDING ELEVATIONS
A211	GLAZING ELEVATIONS
A301	BUILDING SECTIONS
A401	WALL SECTIONS
A402	WALL SECTIONS
A403	WALL SECTIONS
A404	WALL SECTIONS
A405	WALL SECTIONS
A501	EXTERIOR PLAN DETAILS
A502	EXTERIOR PLAN DETAILS
A510	INTERIOR PLAN DETAILS
A511	INTERIOR PLAN DETAILS
A521	SECTION DETAILS
A531	ROOF DETAILS
A601	DOOR SCHEDULE
A603	WINDOW ELEVATIONS - CURTAIN WALL
A604	WINDOW ELEVATIONS - STOREFRONT
A801	ENLARGED TOILET ROOM PLANS & DETAILS
A802	ENLARGED TOILET ROOM PLANS & DETAILS
A803	ENLARGED PLAN - CLASSROOM/PRESS
A804	ENLARGED PLAN - ADMINISTRATION SUITE
A805	ENLARGED PLAN - KITCHEN & BEDROOMS
A806	ENLARGED PLAN - EMERGENCY OPERATIONS CENTER
A807	ENLARGED PLAN - COMMUNICATIONS CENTER
A810	CORRIDOR ELEVATIONS
A841	CASEWORK SCHEDULE
A851	SIGNAGE SCHEDULE AND DETAILS
A900.1	FINISH SCHEDULE
A900.2	FINISH SPECIFICATIONS
A901	FIRST FLOOR FINISH PLAN
A201	ALT. 1 - ANCILLARY BUILDING ELEVATIONS

Structural

S901	STRUCTURAL NOTES
S101	FOUNDATION PLAN
S140	ROOF FRAMING PLAN
S201	GIRT FRAMING PLAN
S301	FOUNDATION DETAILS
S302	COLUMN SCHEDULES, PEIR AND BASE PLATE DETAILS
S303	FOUNDATION DETAILS
S401	MASONRY DETAILS
S501	TYPICAL STEEL DETAILS
S502	BRAKED FRAMED ELEVATIONS & DETAILS
S503	ROOF SECTIONS
S504	ROOF SECTIONS

Mechanical

M-001	Mechanical Notes, Symbols and Abbreviations
M-002	Mechanical Controls and Instrumentation Legend
M-101	FIRST FLOOR PLAN - HVAC
M-201	FIRST FLOOR PLAN - HVAC PIPING
M-301	MECHANICAL ROOF PLAN
M-501	MECHANICAL DETAILS
M-502	MECHANICAL DETAILS
M-503	MECHANICAL DETAILS
M-601	MECHANICAL SCHEDULES
M-602	MECHANICAL SCHEDULES

Electrical

E-001	Electrical Notes, Symbols and Abbreviations
E-002	MECHANICAL EQUIPMENT SCHEDULE
E-100	ELECTRICAL SITE PLAN
E-101	ELECTRICAL FIRST FLOOR PLAN - POWER/DATA
E-102	ELECTRICAL ROOF PLAN - POWER/GROUNDING
E-201	ELECTRICAL FIRST FLOOR PLAN - LIGHTING
E-301	ELECTRICAL FIRST FLOOR PLAN - FIRE ALARM
E-401	ELECTRICAL FIRST FLOOR - PART PLANS
E-402	ELECTRICAL FIRST FLOOR - PART PLANS
E-403	ELECTRICAL FIRST FLOOR - PART PLANS
E-501	ELECTRICAL RISER DIAGRAM
E-502	ELECTRICAL DETAILS - GROUNDING
E-503	ELECTRICAL DETAILS
E-504	FIRE ALARM RISER DIAGRAM

E-101L	SITE LIGHTING PLAN
E100L1	LIGHTING FIXTURE STUDY (DUKE)
E100L2	LIGHTING LUMINAIRE SPECIFICATIONS

Plumbing

P-001	Plumbing Notes, Symbols and Abbreviations
P-100	UNDERSLAB PLUMBING PLAN
P-101	FIRST FLOOR - SANITARY VENT
P-103	ROOF PLAN PLUMBING
P-201	FIRST FLOOR - DOMESTIC WATER PIPING
P-201	SANITARY VENT RISER DIAGRAM
P-202	DOMESTIC WATER RISER DIAGRAM
P-303	STORM WATER RISER DIAGRAM
P-401	PLUMBING DETAILS
P-402	PLUMBING DETAILS
P-401	PLUMBING SCHEDULES

Telecom

T101	FIRST FLOOR PLAN
T102	PARTIAL FIRST FLOOR PLAN

Fire Protection


F-001	Fire Protection Notes, Symbols and Abbreviations
F-101	FIRST FLOOR PLAN - FIRE PROTECTION

▬ DENOTES SHEETS INCLUDED IN SITE PLAN SUBMITTAL SET

ISSUED FOR:

NO.	DESCRIPTION	DATE

DATE: 07/22/2020
SG PROJECT NUMBER: 19-027

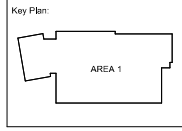

Drawing Title:
COVER SHEET

Drawing Number:
CS.1